
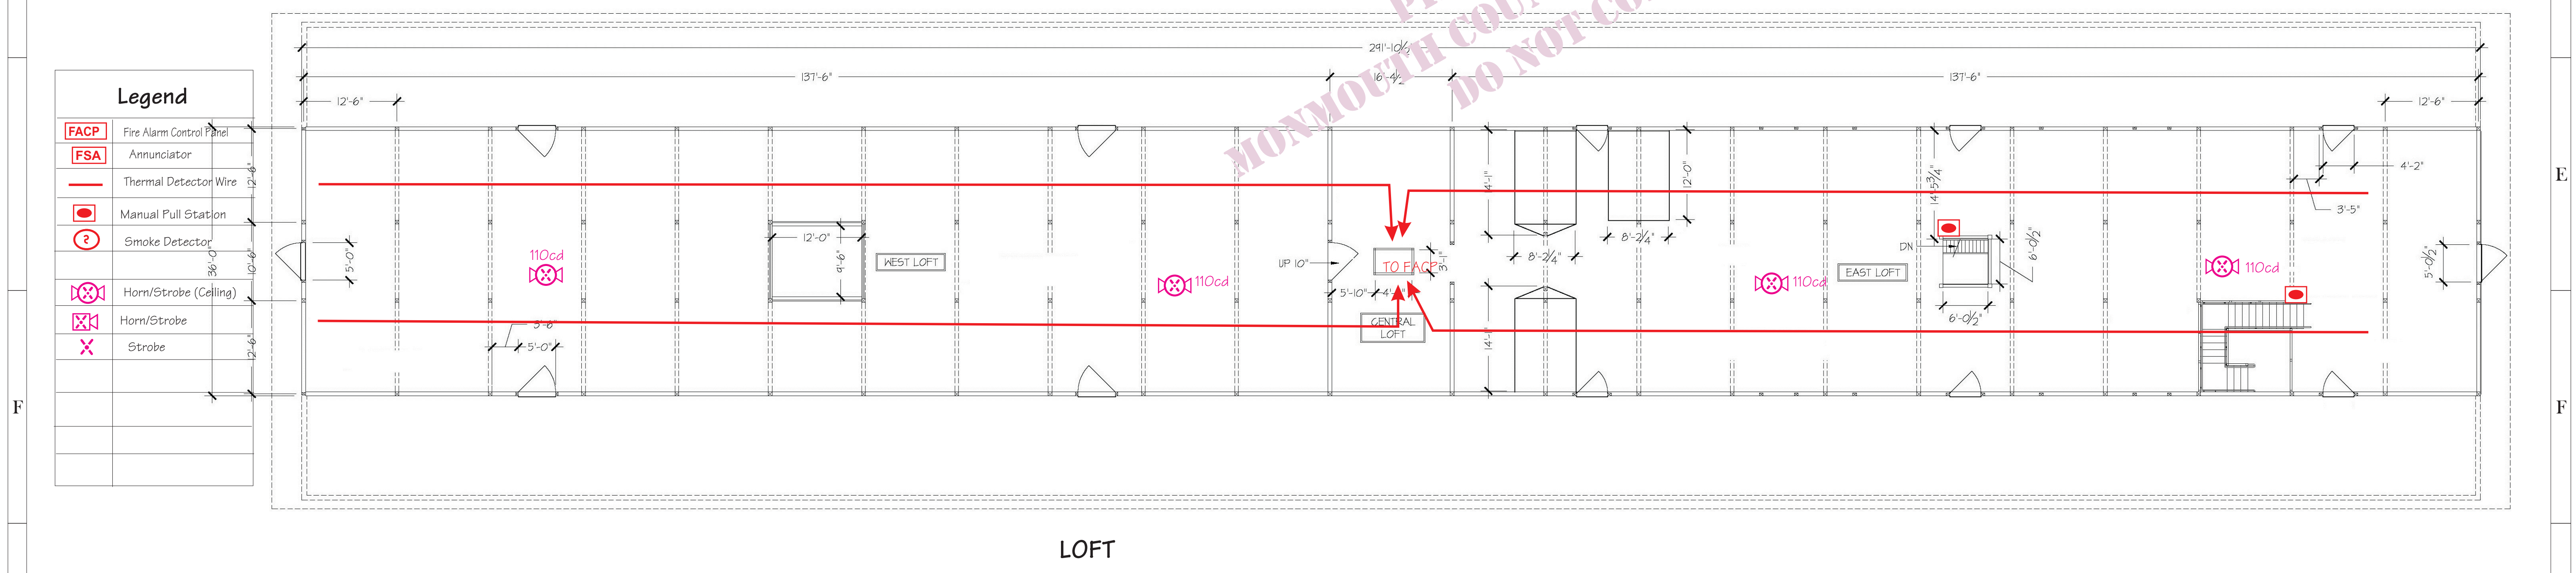


SHOP DRAWINGS

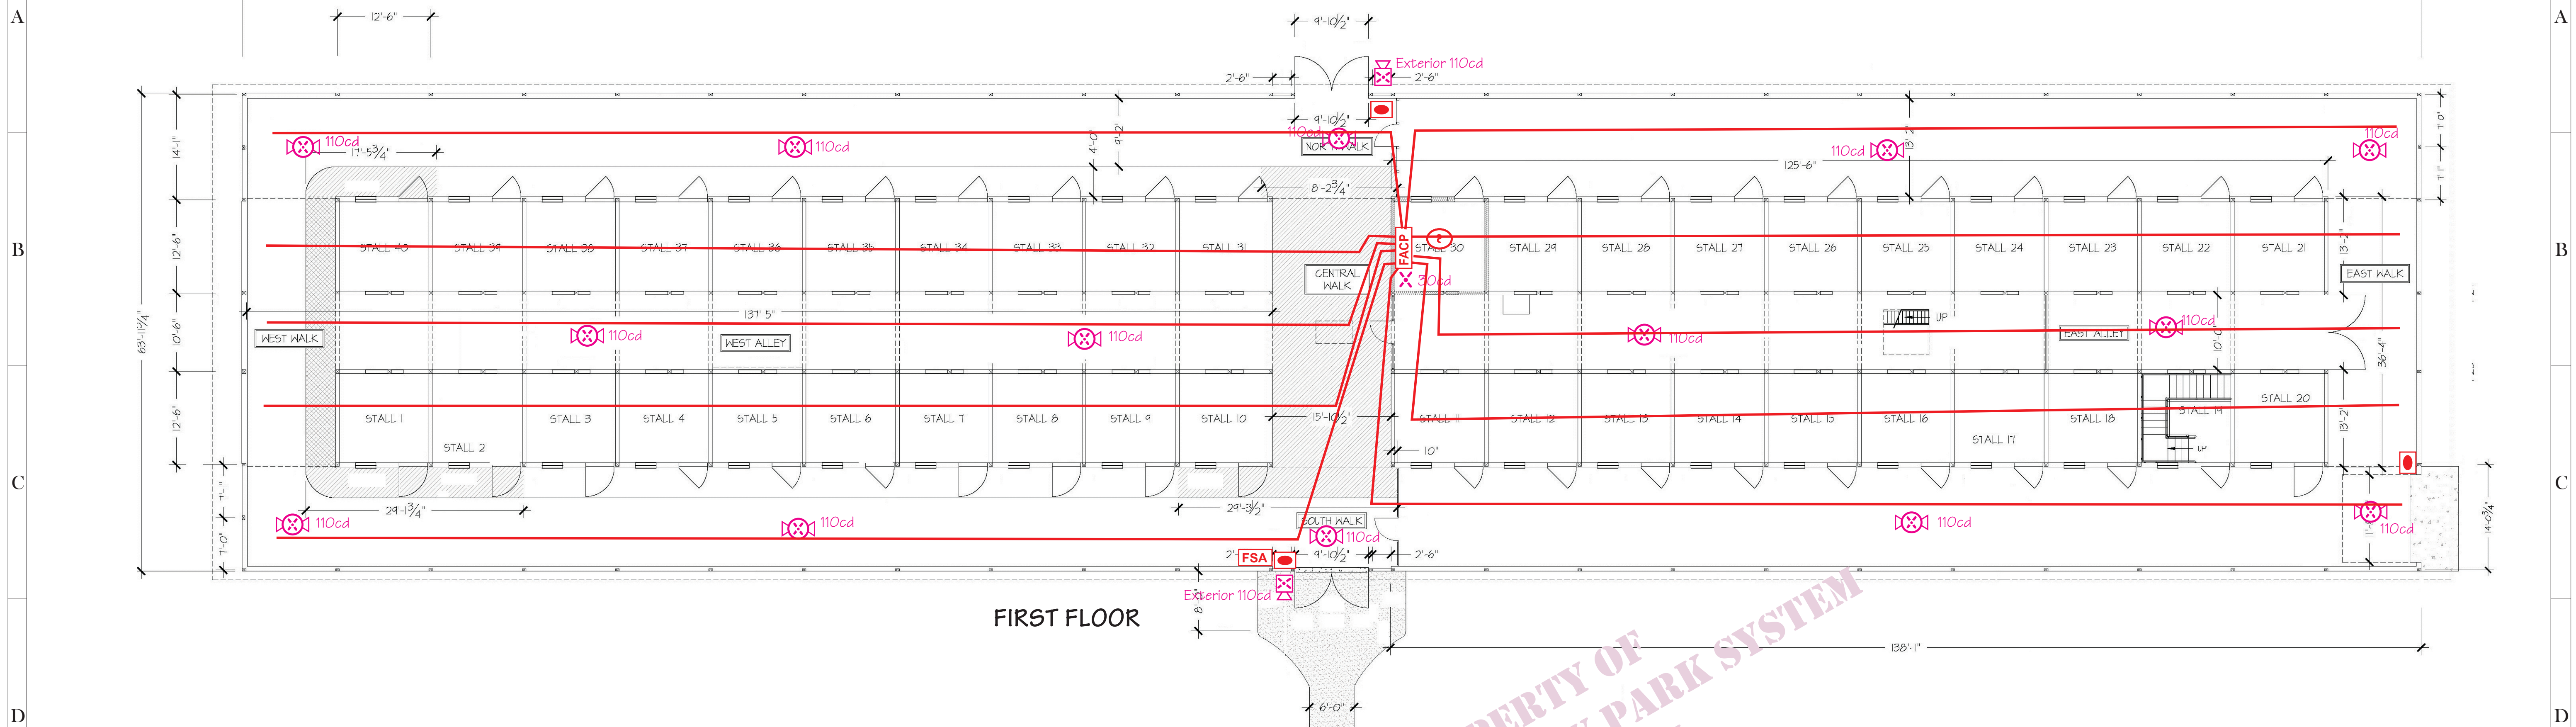

Legend

	Fire Alarm Control Panel
	Annunciator
	Thermal Detector Wire
	Manual Pull Station
	Smoke Detector
	Horn/Strobe (Ceiling)
	Horn/Strobe
	Strobe

PROPERTY OF
MONMOUTH COUNTY PARK SYSTEM
DO NOT COPY

COMPLETE SECURITY SYSTEMS, INC.
 94 Vanderburg Road
 Marlboro, NJ 07746
 (732) 780-6787
 Fax: (732) 845-4789
 info@completesecuritysystems.com
 http://www.completesecuritysystems.com
 NJ Fire Protection Equipment Contractor Business Permit Number P00064
 NJ Home Improvement Contractor Business Permit Number 13VH00506400
 NY Fire and Security Alarm Installer Unique ID Number 12000318099

Monmouth County Park System - Thompson Park
 Proposed Automatic Fire Alarm System
 805 Newman Sprints Road, Lincroft, NJ 07738
 (Middletown Township Block 1099, Lot 8)

JOB NO:	DRAWN BY: Bob Pflieger NICET II # 121485	FILE NAME: Barn.cdr	DATE:	NOTES:
DATE:	DESIGN BY: Lance Brooks			
SCALE: 3/32" = 1'	THIS DRAWING, DESIGN, AND DETAIL ARE THE PROPERTY OF COMPLETE SECURITY SYSTEMS, INC., AND IS SUBMITTED FOR CONFIDENTIAL INSPECTION. IT IS NOT TO BE COPIED OR USED IN ANY MANNER WITHOUT THE EXPRESSED WRITTEN CONSENT OF COMPLETE SECURITY SYSTEMS, INC.			
SIZE:				

THOMPSON PARK, LINCROFT (Middletown Twp.), NJ

FA-1